


ROOM DEMOLITION SCHEDULE

ROOM NO.	DEMOLITION	FLOOR	CEILING	PHOTOGRAPH DETAILS	ROOM NO.	DEMOLITION	FLOOR	CEILING	PHOTOGRAPH DETAILS
N 2100	REMOVE WALL				2531	REMOVE WALL, DOOR & FRAME			
2101					2532	REMOVE WALL, DOOR & FRAME			
2102					2534				
2103					2535	TOTAL REMOVAL			
2104					2535A	TOTAL REMOVAL			
2105					2535B	TOTAL REMOVAL			
2106					2536	TOTAL REMOVAL			
M 2107	REMOVE WALL				2531	TOTAL REMOVAL			
2108	REMOVE WALL				2538	REMOVE WALL			
2109	REMOVE PLUMBING FIXTURES, TOILET PARTITIONS				2539	REMOVE PLUMBING FIXTURES			
2110					2540	REMOVE WALL, DOOR & FRAME			
2114	REMOVE WALL, DOORS & FRAMES				2541	TOTAL REMOVAL			
2117	REMOVE DOOR & FRAME				2544	REMOVE DOOR & FRAME			
2119	REMOVE WALL, PLUMBING FIXTURES, TOILET PARTITIONS								
L 2121	REMOVE WALL								
2201					2600				
2202					2601				
2203					2602				
2204					2603				
2206					2604				
K 2207					2605				
2208					2606				
2209					2607				
2210					2608				
2211					2609				
2212					2610				
J 2305					2611				
					2612				
					2613				
					2614				
					2615				
					2616				
					2617				
					2618				
					2619				
					2620				
					2621				
					2622				
					2623				
					2624				
					2625				
					2626				
					2627				
					2628				
					2629				
					2630				
					2631				
					2632				
					2633				
					2634				
					2635				
					2636				
					2637				
					2638				
					2639				
					2640				
					2641				
					2642				
					2643				
					2644				

ROOM NO.	DEMOLITION	FLOOR	CEILING	PHOTOGRAPH DETAILS
2122	REMOVE WALL, DOOR & FRAME CASEWORK			
2122A	REMOVE W.C.			
2123	REMOVE WALL, DOOR & FRAME CASEWORK			
2123A	REMOVE WALL, DOOR & FRAME PLUMBING FIXTURES			
2124	REMOVE WALL, DOOR & FRAME CASEWORK			
2124A	REMOVE W.C.			
2125	REMOVE WALL, DOOR & FRAME CASEWORK			
2125A	REMOVE WALL, DOOR & FRAME PLUMBING FIXTURES			
2126	TOTAL REMOVAL			
2127	REMOVE WALL			
2128	TOTAL REMOVAL			
2129	TOTAL REMOVAL			
2130	TOTAL REMOVAL			
2131	TOTAL REMOVAL			
2132	TOTAL REMOVAL			
2133				
2134				
2135	REMOVE WALL, DOOR & FRAME			
2136	TOTAL REMOVAL			
2137	TOTAL REMOVAL			
2138	TOTAL REMOVAL			
2139	TOTAL REMOVAL			
2140	TOTAL REMOVAL			
2141				
2142				
2143				
2144				

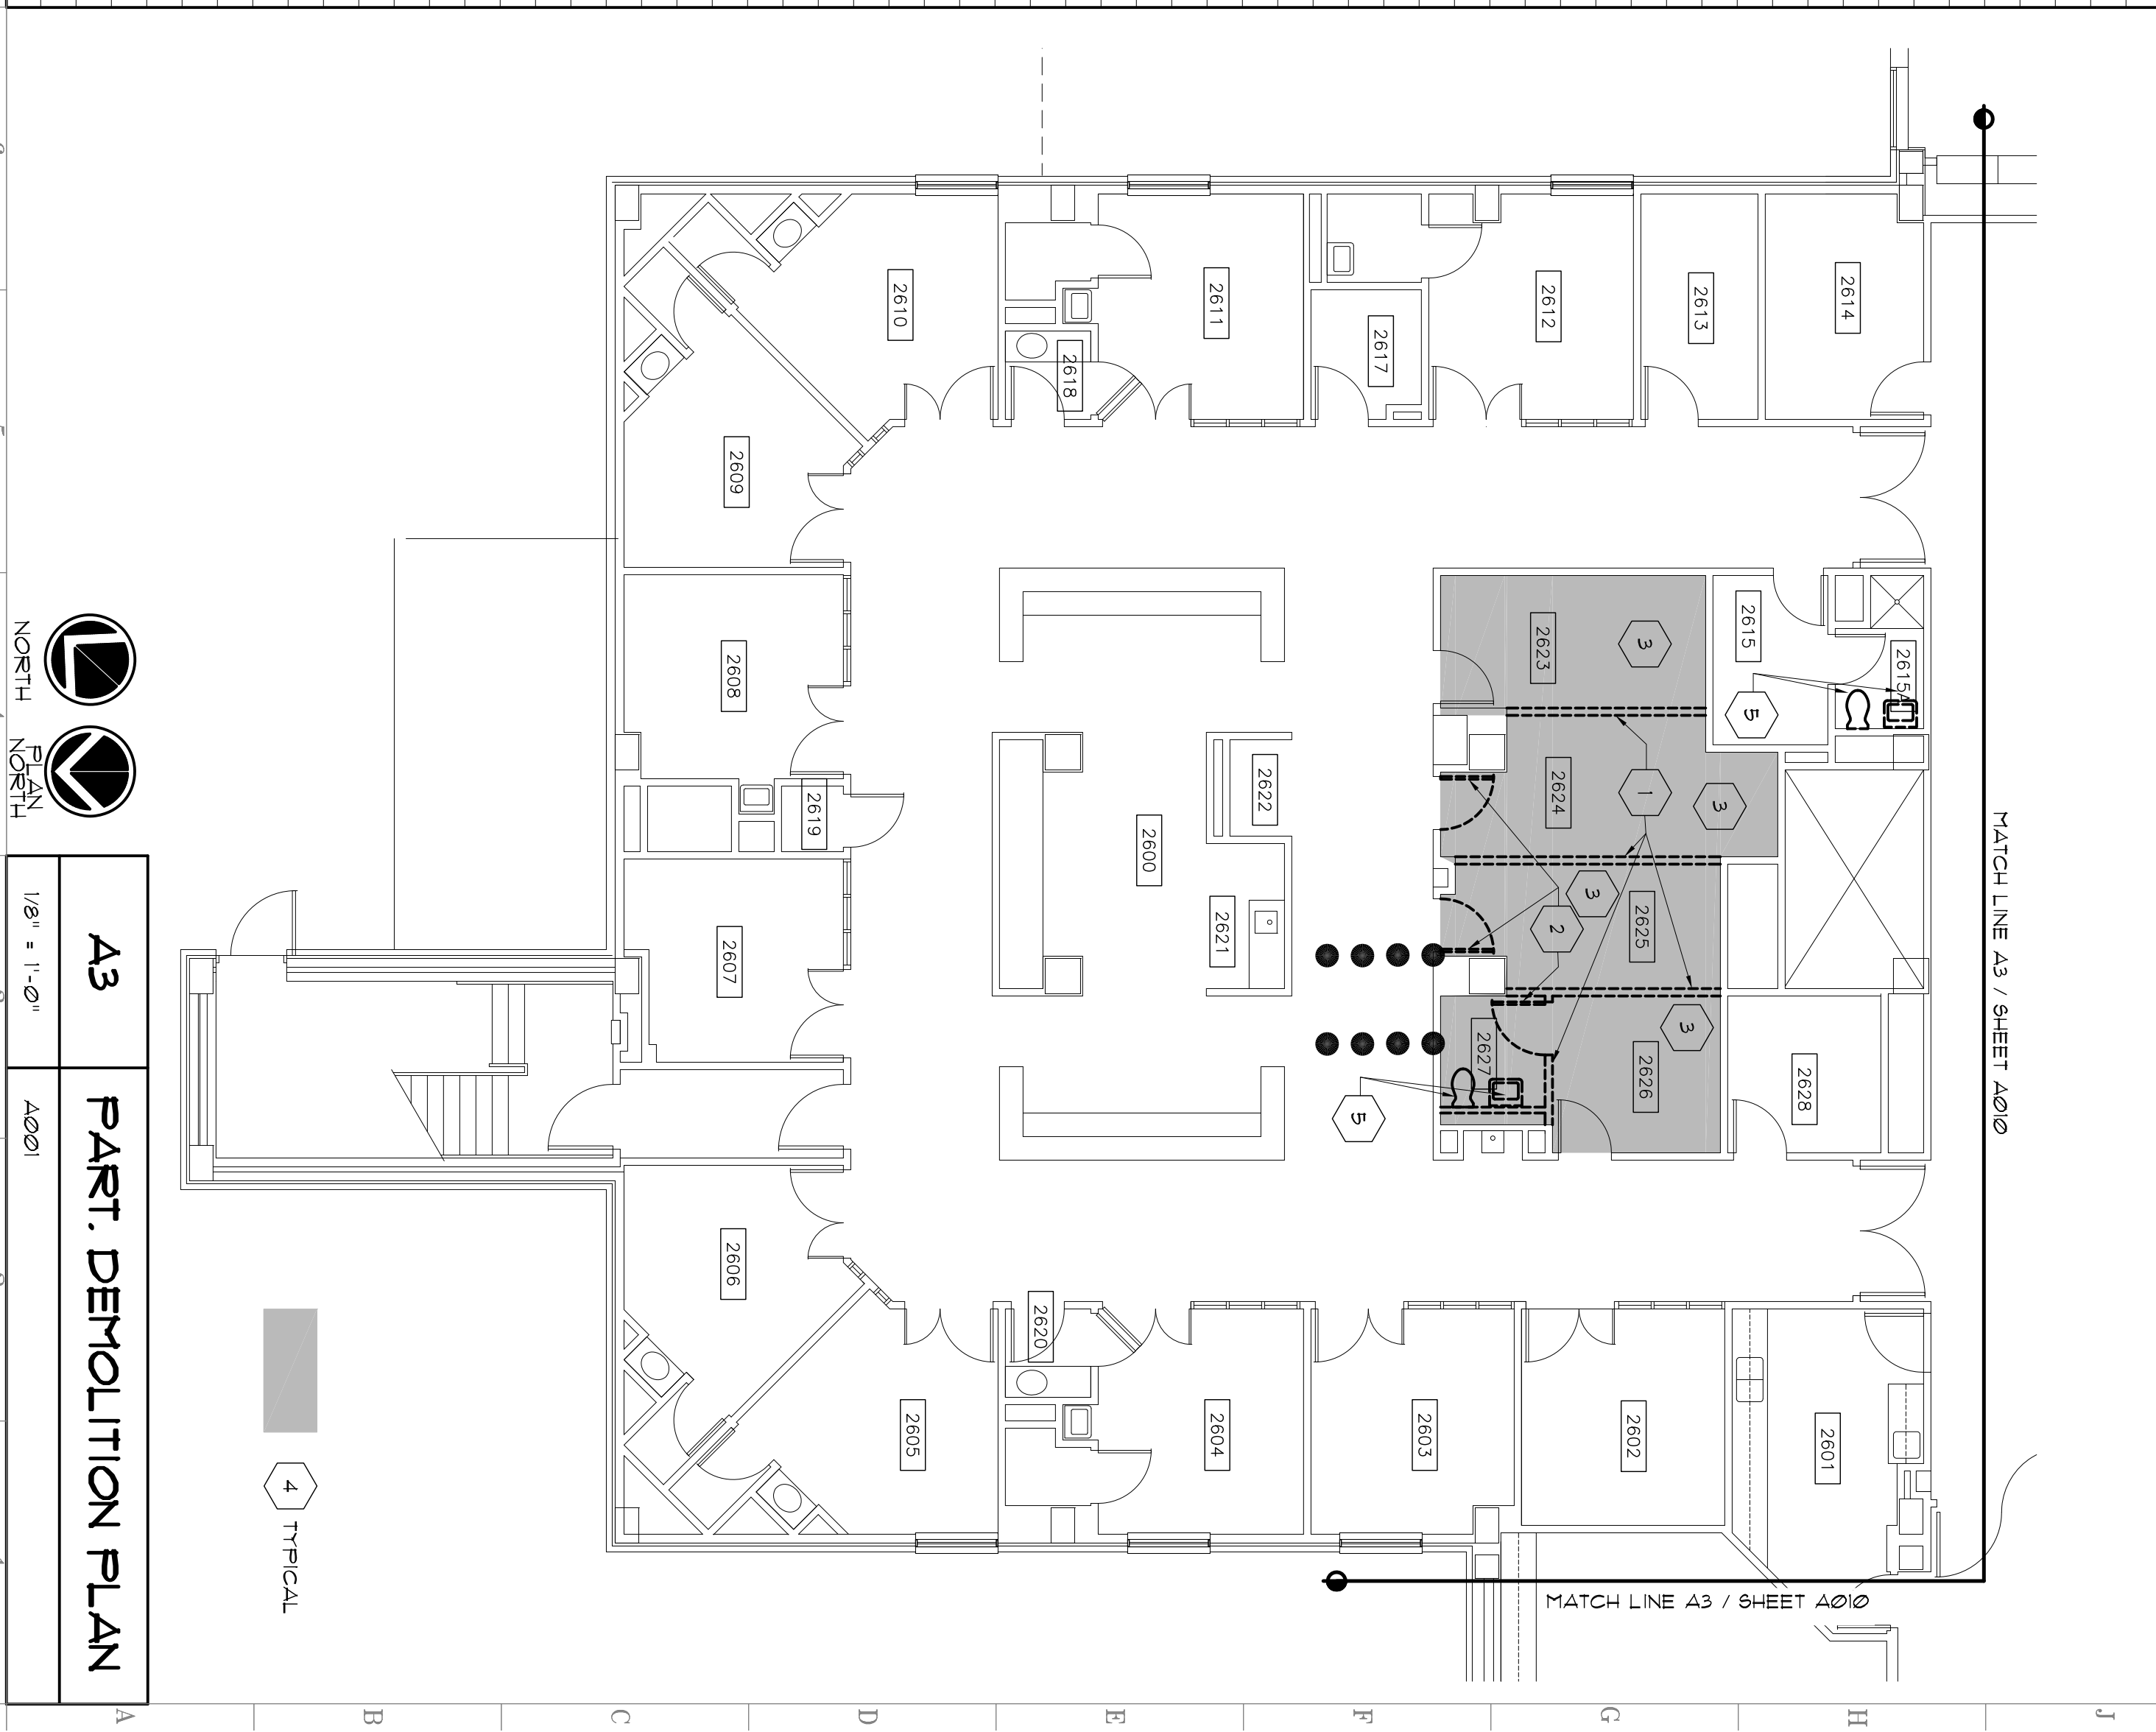

OAKLAND UNIVERSITY
NURSING SCHOOL

RIVERVIEW CAMPUS
DETROIT MICHIGAN



ISSUED FOR: _____ DATE: _____
PERMIT: 0322088

THIS DRAWING AND DESIGN ARE THE PROPERTY OF PAL FRITZ ASSOCIATES ARCHITECTS AND PLANNING. ANY REPRODUCTION OR TRANSMISSION OF THIS DRAWING OR DESIGN WITHOUT THE WRITTEN PERMISSION OF PAL FRITZ ASSOCIATES ARCHITECTS AND PLANNING IS STRICTLY PROHIBITED. ALL RIGHTS ARE HEREBY SPECIFICALLY RESERVED.

© COPYRIGHT © 2008
PAL FRITZ ASSOCIATES ARCHITECTS AND PLANNING
SANTA CLARA SHORES, MICHIGAN 48080

DO NOT SCALE DRAWINGS

SHEET NAME: PARTIAL DEMOLITION PLAN SCHEDULE

SHEET NUMBER: A012

DRAWN BY: PFF

CHECKED: _____

APPROVED: _____

STATE OF MICHIGAN LICENSE 30743
EXPIRES OCTOBER 31, 2008

PROJECT NUMBER: 080102

A3 PART. DEMOLITION PLAN